


SITE PLAN
Scale: 40ft to 1in

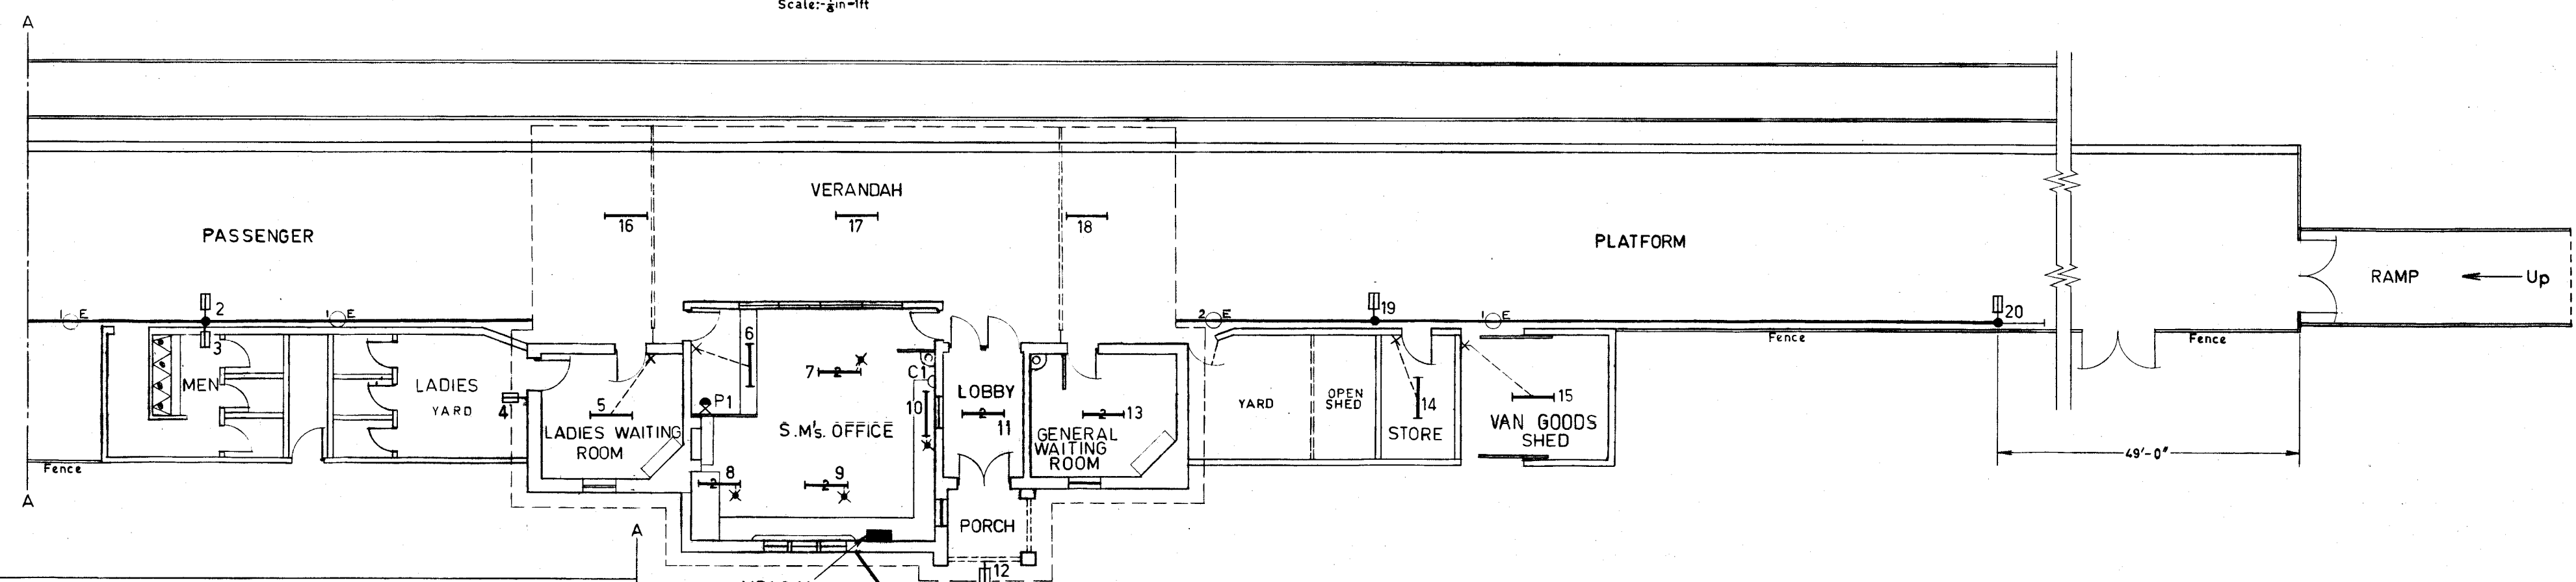

STATION BUILDINGS & PLATFORM
Scale: 1/2 in = 1ft

SYMBOLS

- Steel Pole (Platform Standard)
- Wood Pole
- Light Fitting - General
- " " - Street Lantern - Tubular Fluorescent Lamps - 2 x 20W
- Lamp - Tubular Fluorescent - 40W
- ⊕ XP Switched Plug Socket (G.P.O.)
- ⊕ XP " Extra Low Voltage Outlet (32V)
- ⊖ Clock Outlet
- Switchboard
- × Ceiling Switch

CONDUCTORS & LINES

- | | | |
|--------------------------|---------------|-------------|
| Type of System: | Open Aerials: | N.S. Cable: |
| Active + Neutral | — IN — | — ○ — |
| Active + Neutral + Earth | — INE — | — ○E — |
| 2 Actives | — 2 — | |

Last numbers used:- L27,P2,XP2,C1,DB1,MB1.

VIC. RLYS.
ELEC. ENG. BRANCH

LIGHTING & POWER STATIONS & YARDS

LIGHTING & POWER INSTALLATION
PORT FAIRY STATION & YARD

SCALE: 40ft to 1in & 1/2 in = 1ft	APPROVED
DRAWN: <i>[Signature]</i> DATE: 5-9-67	<i>[Signature]</i>
TRACED: <i>[Signature]</i> DATE: <i>[Signature]</i>	CEE: <i>[Signature]</i>
ENG. DESIGN: <i>[Signature]</i> DRG. OFFICE: <i>[Signature]</i>	L 8119
CHECKED: <i>[Signature]</i> PASSED: <i>[Signature]</i>	A

L 8119