

D.R. NOT CONSTRUCTED
SITE NO LONGER REQUIRED. 2.7.68

LIST OF FITTINGS:


1. W.C. Proposed (6 pint flush)

NOTES:

150.0" Absorption drains type "A" Plan No 728/64. at each D.R.
 444 gal. Precast Septic Tanks to be used.
 Septic Tanks, absorption drains & sillage drains shown Red.
 Drains to Septic Tanks shown Blue.

SITE PLAN.

Note:
floor level to be 2'4" above ground level.

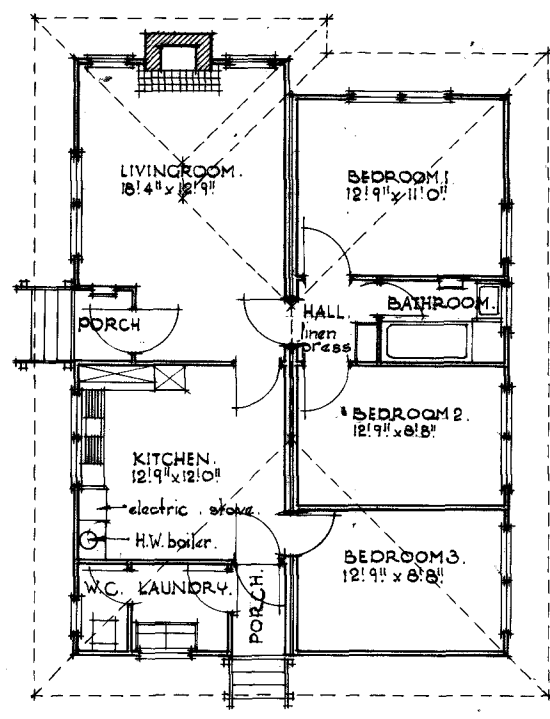

PLAN.

scale 1/8" = 1'-0"

revision	date	amendment	Amend by	drawn	traced	checked	corr. no.	<p>YEA. PROPOSED 2ND D.R. TYPE A. Septic Sewerage & Drainage.</p> <p><i>YEA</i> 15.12.66 Act Chief Civil Engineer.</p>		
			B4	A.A.F.			6150-65	INDEX No	PLAN	
								1154-4	913/6	

1154-4